


DATE	ISSUE
22 SEPT 2009	CONCEPT
5 OCT 2009	PERMIT
2 NOV 2009	CHANGE
9 NOV 2009	PERMIT
8 JAN 2010	REV PERMIT

TENANT IMPROVEMENTS FOR
CRC INSTITUTE GREEN TRAINING CENTER
PEARL PLAZA SHOPPING CENTER, SUITE 03
2808 NORTH PEARL PLAZA, JACKSONVILLE, FLORIDA 32208

ELECTRICAL LIGHTING PLAN

PROJECT NO:	09088
DRAWN BY:	JBS
CHECKED BY:	JBS
SHEET NO:	

E2.1
SHEET

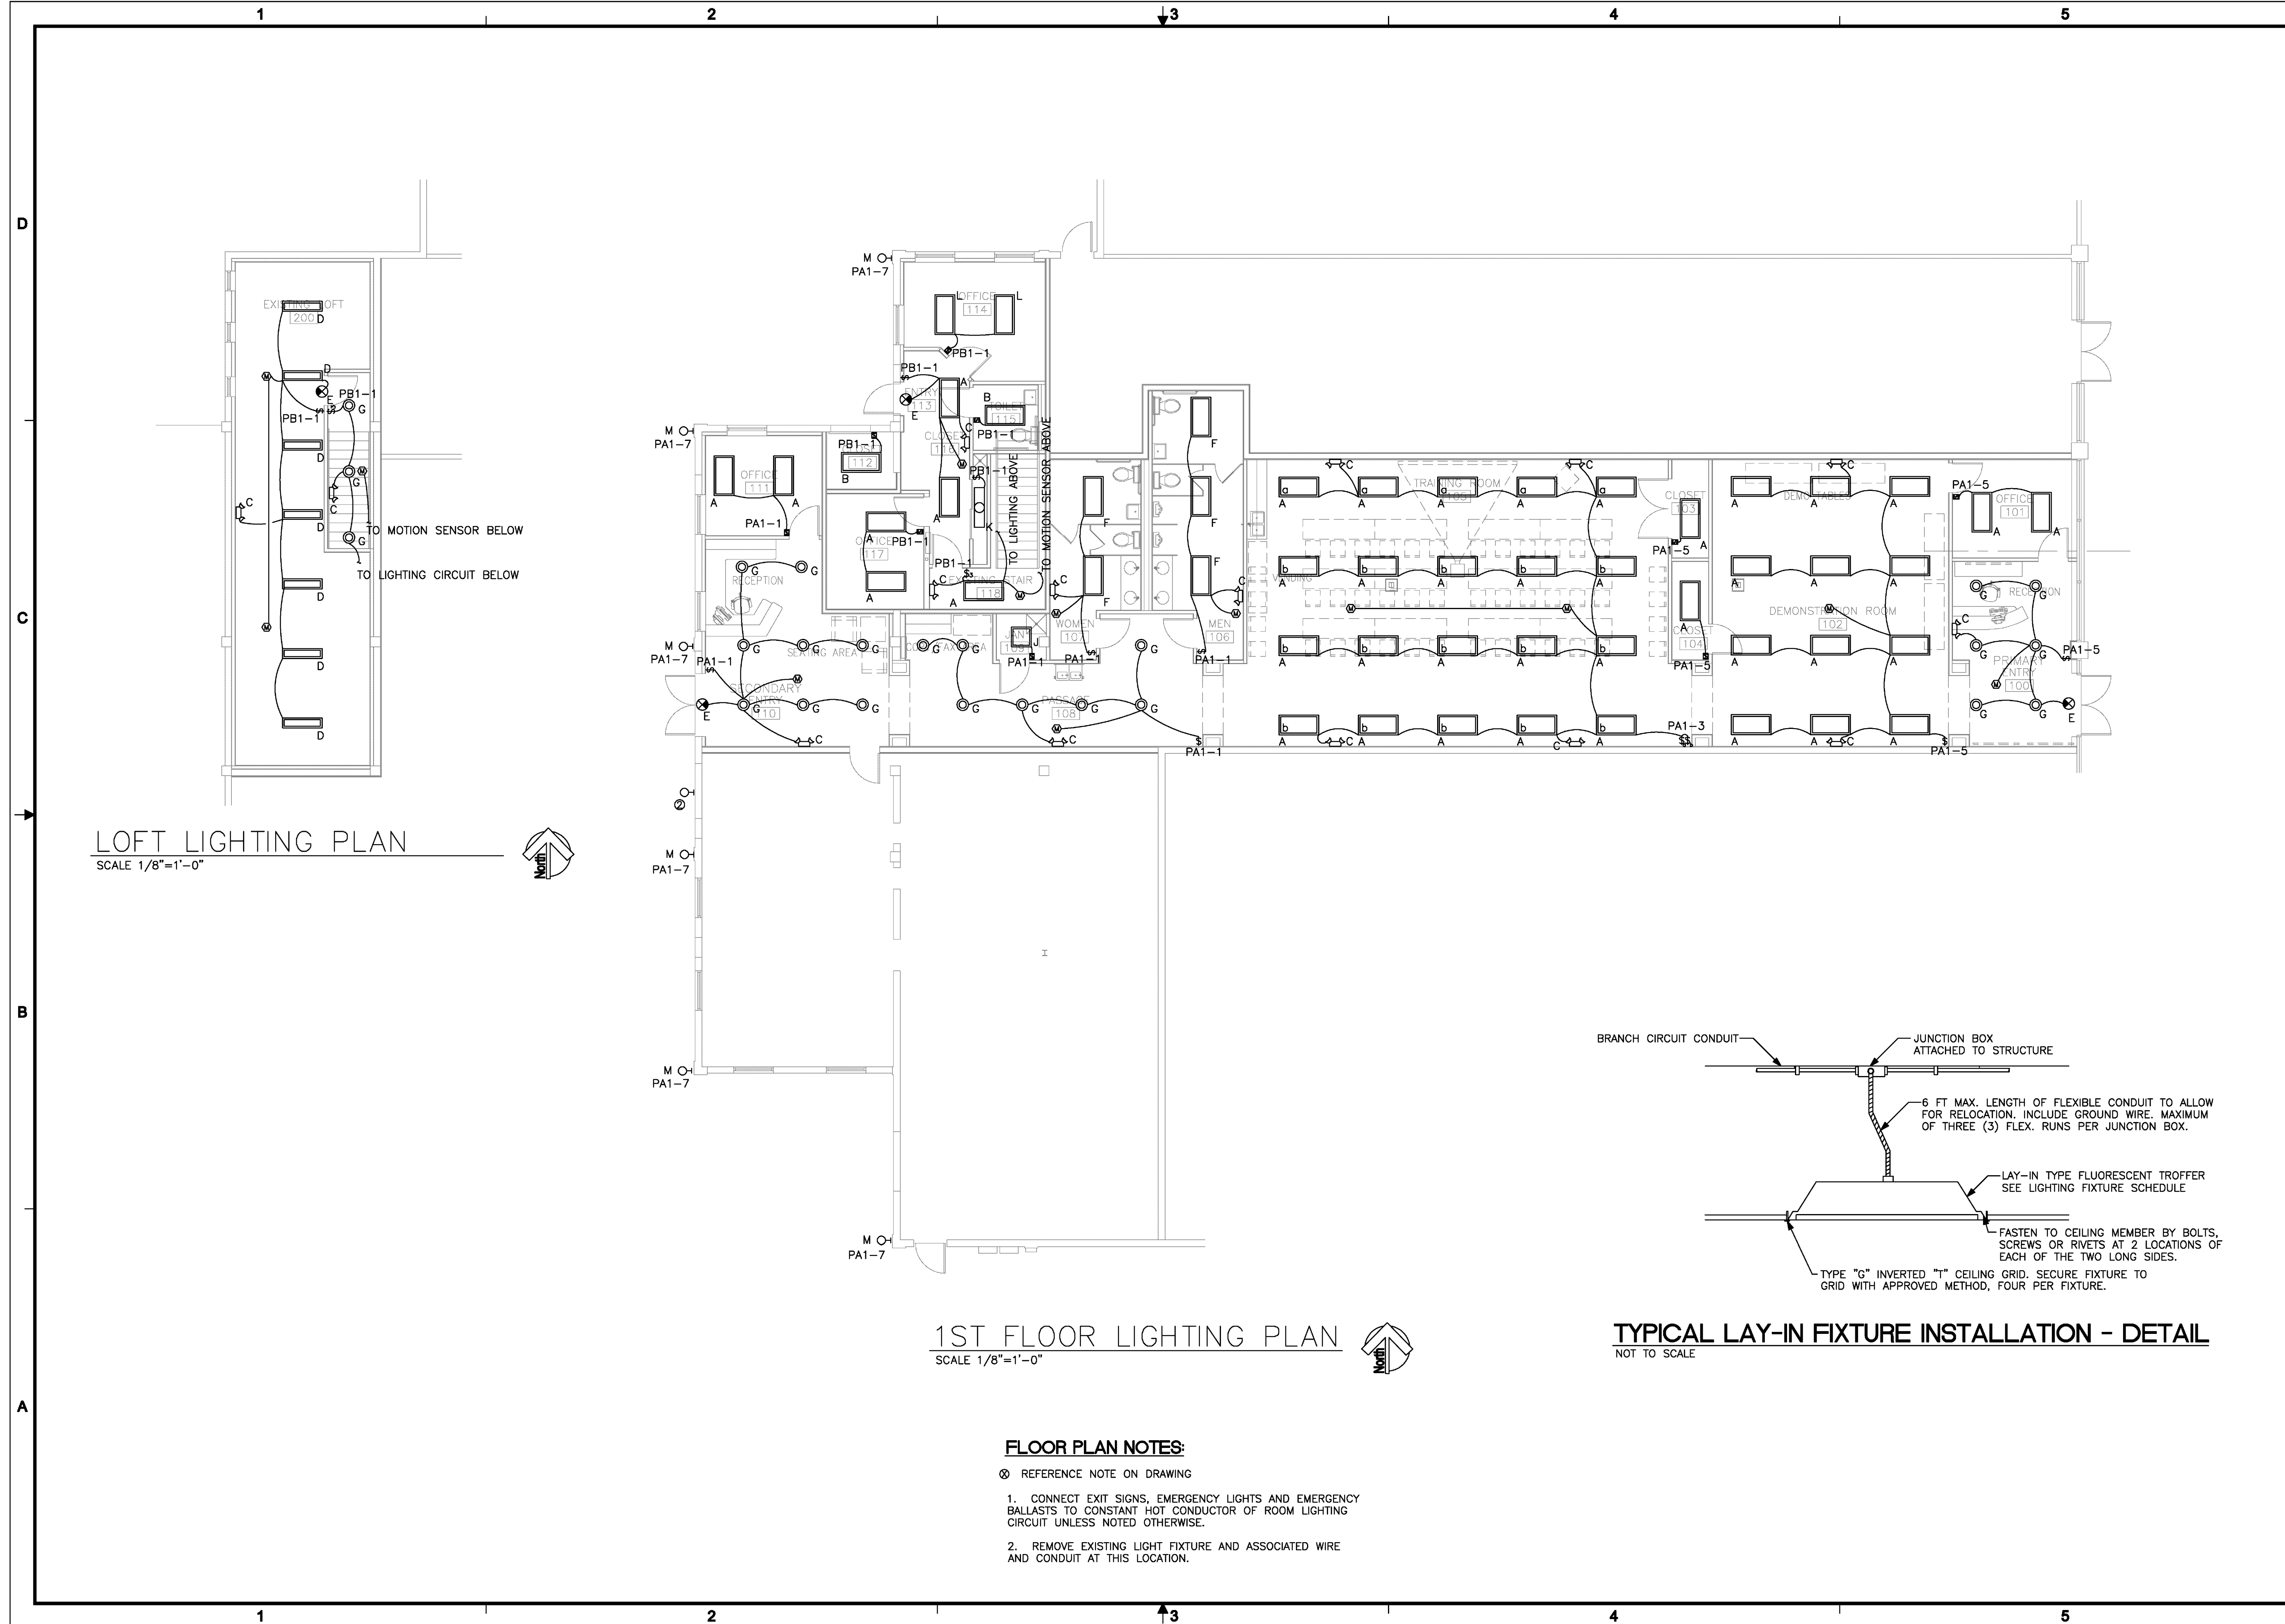

LOFT LIGHTING PLAN
SCALE 1/8"=1'-0"

1ST FLOOR LIGHTING PLAN
SCALE 1/8"=1'-0"

TYPICAL LAY-IN FIXTURE INSTALLATION - DETAIL
NOT TO SCALE

- FLOOR PLAN NOTES:**
- ⊗ REFERENCE NOTE ON DRAWING
 - 1. CONNECT EXIT SIGNS, EMERGENCY LIGHTS AND EMERGENCY BALLASTS TO CONSTANT HOT CONDUCTOR OF ROOM LIGHTING CIRCUIT UNLESS NOTED OTHERWISE.
 - 2. REMOVE EXISTING LIGHT FIXTURE AND ASSOCIATED WIRE AND CONDUIT AT THIS LOCATION.